

Revisions

A	05/05/2017	CONCEPT DESIGN
B	09/05/2017	CONCEPT DESIGN
C	20/10/2017	CONCEPT DESIGN
D	01/12/2017	CONCEPT DESIGN
E	05/12/2017	CONCEPT DESIGN
F	08/02/2018	CONCEPT DESIGN
G	12/09/2018	CONCEPT DESIGN

Notes

KEY

- CIRCULATION
- DENTAL
- EDIPU - EMERGENCY
- EDIPU - INPATIENT
- EDIPU CORE SUPPORT
- ENGINEERING
- IFHC - EXTERNAL STORE
- IFHC - RECEPTION / WAITING
- IFHC - CORE SPACE
- IFHC - CORE SUPPORT
- IFHC - RADIOLOGY
- PATHOLOGY
- STAFF RESOURCES



Consultants

Calibre Consulting Ltd  
Project Manager  
Aecom  
Structural Engineer  
Mechanical Engineer  
Olsson Fire & Risk  
Fire Engineer

Electrical Engineer

Olsson Fire & Risk  
Fire Engineer

Client

MINISTRY OF HEALTH

Warren and Mahoney Architects Ltd

254 Montreal Street  
PO Box 25086  
Christchurch 8011  
New Zealand  
Phone + 64 3 961 5926

Registered Architects and Designers  
www.warrenandmahoney.com

Project Title

**7778 MOH BULLER INTEGRATED HEALTH**  
PAKINGTON STREET, BULLER.

Drawing Title

**FLOOR PLAN**

Drawing Status


**CONCEPT DESIGN**

Drawing Details

Scale 1 : 100 @ A1  
Date 09/02/2018  
Job No 7778  
Drawn AT  
Checked JR

Drawing No Revision

A01.001 (G)

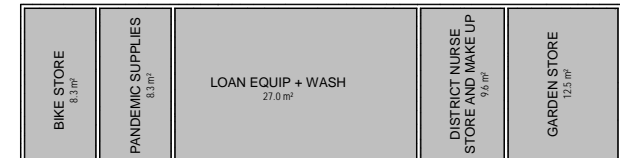

**2 UTILITY BUILDING - PLAN**  
A02.001 1:100